


The below data points and elevations were based on the borings and test pits completed on the site. Frimpter adjusted groundwater was provided by Geo Hydro Cycle.

Data Point	Bottom of Boring - B Bedrock - BR Observed Groundwater - OGW SHGW - SHGW Frimpter Adjusted - FA Redoximorphic Features - RF	Proposed Finish Grade
EW-1 EW-2 MW-3 MW-3A MW-5 MW-6 MW-9DX MW-2	The Data Points listed to the left are located in areas where there is not any grading proposed.	170.00 Bottom of infiltration basin # 2
MW-10	168.26 BR	213.5
MW-11	177.41 FA	216.5
MW-12	169.90 FA	202.0 Fill
MW-13	177.37 FA	216.0
MW-1DX	173.57 OGW	202.0 Fill
MW-2DX	172.88 B	197.0
MW-3DX	164.84 OGW	190.0
MW-5DX	183.3 B	201.5
MW-6DX	198.54 B	212.5 Fill
MW-7DX	178.99 FA	227.0
MW-8DX	171.02 B	202.0
GHC-1	179.45 FA	226.5
GHC-2	183.01 FA	221.0 Fill
GHC-3	205.0 BR	225.0
B-14	177.1 BR	185.5 Fill
B-15	169.6 BR	182.0
GW-1	167.85 RF	172.00 Bottom of Infiltration Basin # 1
GW-2	165.33 RF	170.00 Bottom of Infiltration Basin # 2
GW-3	163.19 RF	168.00 Bottom of Infiltration Basin # 3

NOTE:  
BEDROCK CONTOURS WERE PROVIDED BY GEO HYDRO CYCLE. THEY ARE BASED ON MONITOR WELLS AND TEST PITS LOCATED ON THE SITE. WHERE TESTING WAS NOT CONDUCTED, THE BEDROCK CONTOURS WERE BASED ON EXISTING GRADE ELEVATIONS.

DATE	FIELD BY:	INT.
BK#	FIELD BOOK	PG#
5/18	CALCS BY:	RRG
5/18	DESIGNED BY:	RRG
5/18	DRAWN BY:	COMP
5/18	CHECKED BY:	CAQ

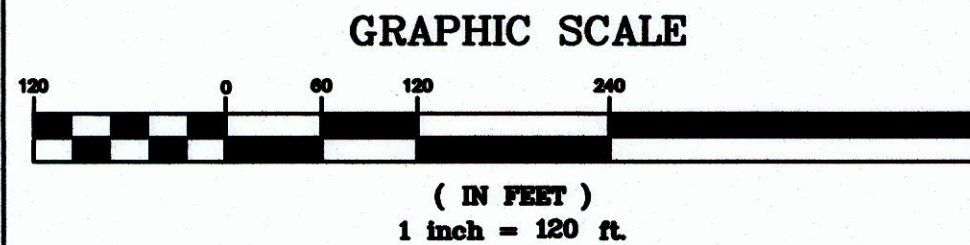

NO.	DATE	DESCRIPTION	BY

THE PRESERVE AT ABBYVILLE  
& ABBYVILLE COMMONS  
GRADING AND BEDROCK  
ILLUSTRATION PLAN  
NORFOLK, MASSACHUSETTS  
FOR  
ABBYVILLE DEVELOPMENT, LLC.  
& ABBYVILLE RESIDENTIAL, LLC  
850 FRANKLIN STREET  
WRENTHAM, MASSACHUSETTS  
DATE: MAY 17, 2018  
SCALE: 1" = 120'

UNITED  
CONSULTANTS  
INC.  
850 FRANKLIN STREET SUITE 11D  
WRENTHAM, MASSACHUSETTS 02093  
508-384-6560 FAX 508-384-6566



DATE  
MAY 17, 2018

SCALE  
1" = 120'

PROJECT  
UC987


SHEET  
1 OF 8



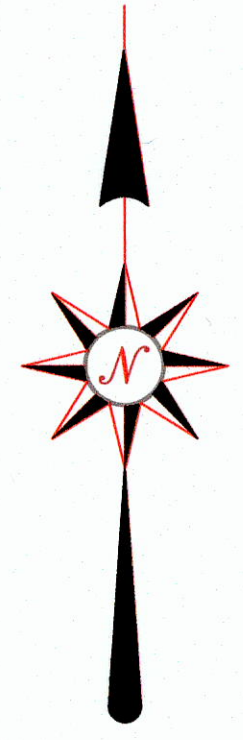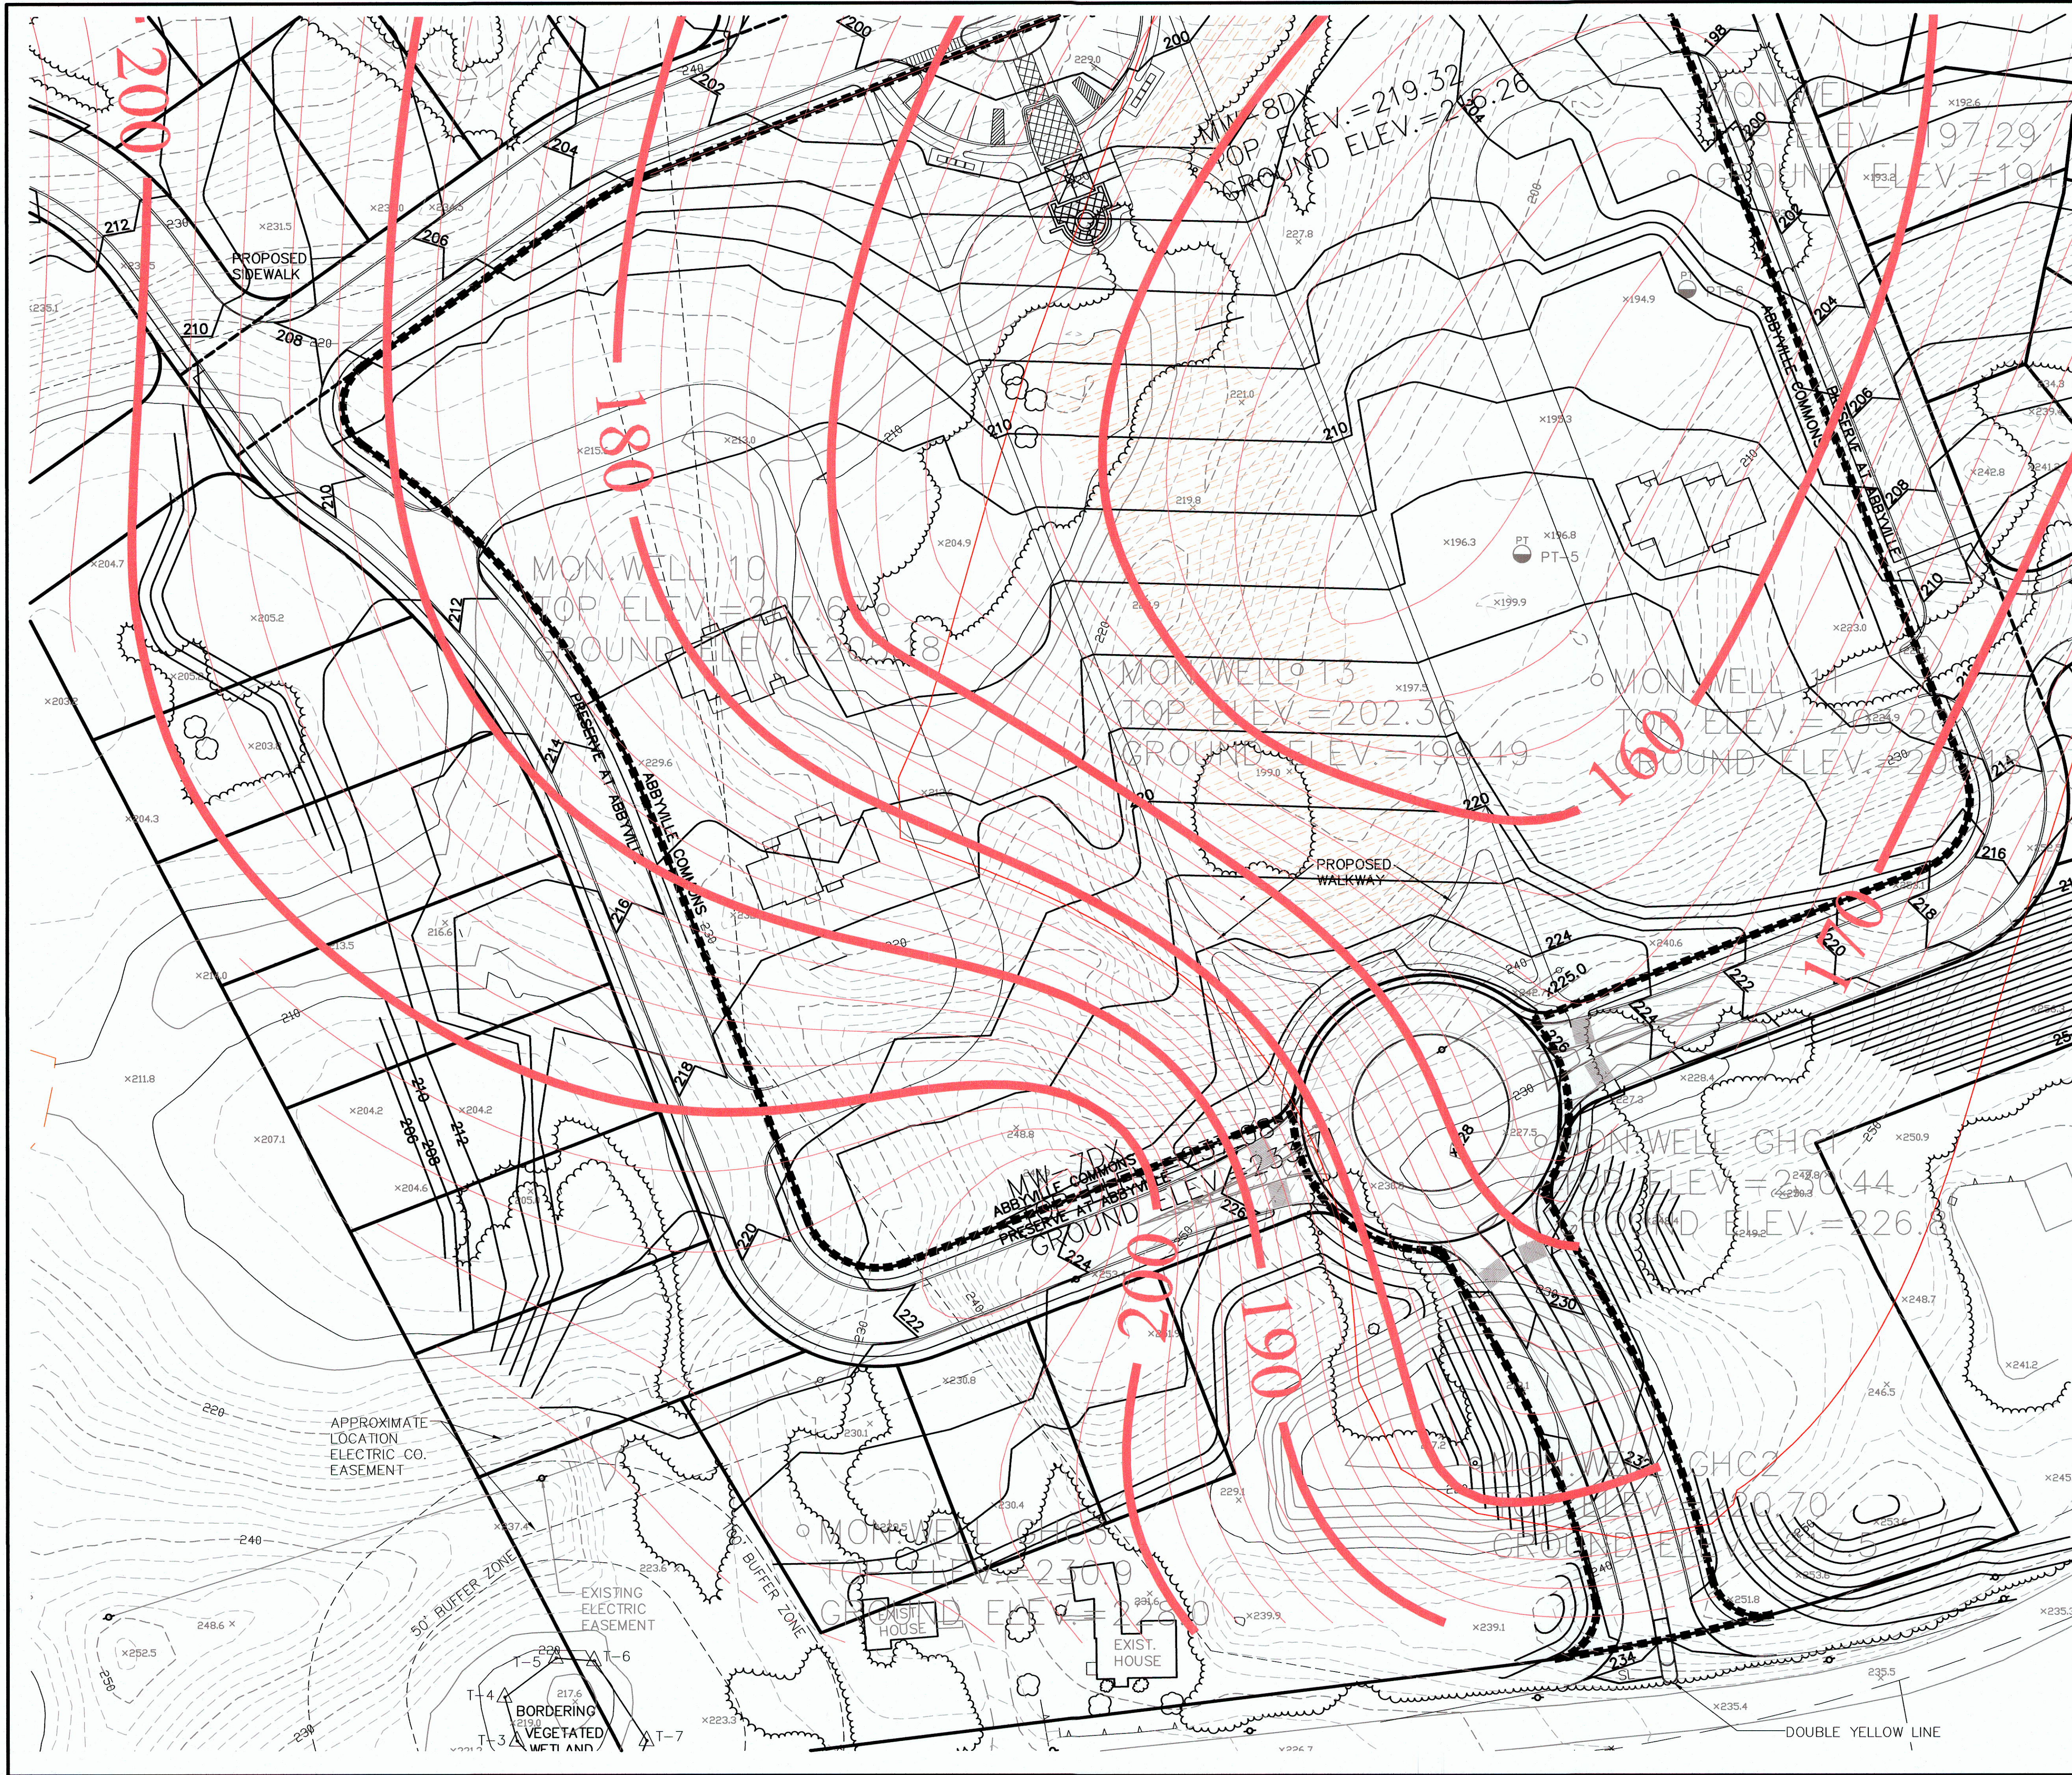

NOTE:  
BEDROCK CONTOURS WERE  
PROVIDED BY GEO HYDRO CYCLE.  
THEY ARE BASED ON MONITOR  
WELLS AND TEST PITS LOCATED  
ON THE SITE. WHERE TESTING  
WAS NOT CONDUCTED, THE  
BEDROCK CONTOURS WERE BASED  
ON EXISTING GRADE ELEVATIONS.

DATE	FIELD BY:	INT.
BK#	FIELD BOOK	PG#
5/18	CALCS BY:	RRG
5/18	DESIGNED BY:	RRG
5/18	DRAWN BY:	COMP
5/18	CHECKED BY:	CAQ

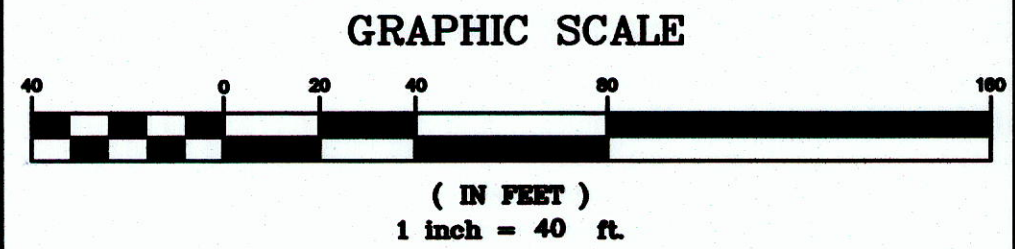

NO.	DATE	DESCRIPTION	BY

THE PRESERVE AT ABBYVILLE  
& ABBYVILLE COMMONS  
GRADING AND BEDROCK  
ILLUSTRATION PLAN  
NORFOLK, MASSACHUSETTS  
FOR  
ABBYVILLE DEVELOPMENT, LLC.  
& ABBYVILLE RESIDENTIAL, LLC  
850 FRANKLIN STREET  
WRENTHAM, MASSACHUSETTS  
DATE: MAY 17, 2018  
SCALE: 1" = 40'

**UNITED  
CONSULTANTS  
INC.**  
850 FRANKLIN STREET SUITE 11D  
WRENTHAM, MASSACHUSETTS 02093  
508-384-6560 FAX 508-384-6566

DATE	MAY 17, 2018
SCALE	1" = 40'
PROJECT	UC987
SHEET	2 OF 8






NOTE:  
BEDROCK CONTOURS WERE  
PROVIDED BY GEO HYDRO CYCLE.  
THEY ARE BASED ON MONITOR  
WELLS AND TEST PITS LOCATED  
ON THE SITE. WHERE TESTING  
WAS NOT CONDUCTED, THE  
BEDROCK CONTOURS WERE BASED  
ON EXISTING GRADE ELEVATIONS.

THE PRESERVE AT ABBYVILLE  
& ABBYVILLE COMMONS  
GRADING AND BEDROCK  
ILLUSTRATION PLAN  
NORFOLK, MASSACHUSETTS  
FOR  
ABBYVILLE DEVELOPMENT, LLC.  
& ABBYVILLE RESIDENTIAL, LLC  
850 FRANKLIN STREET  
WRENTHAM, MASSACHUSETTS  
DATE: MAY 17, 2018  
SCALE: 1" = 40'


**UNITED  
CONSULTANTS  
INC.**  
850 FRANKLIN STREET SUITE 11D  
WRENTHAM, MASSACHUSETTS 02093  
508-384-6560 FAX 508-384-6566



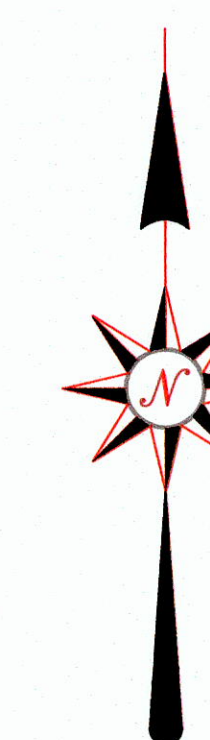

NOTE:  
BEDROCK CONTOURS WERE  
PROVIDED BY GEO HYDRO CYCLE.  
THEY ARE BASED ON MONITOR  
WELLS AND TEST PITS LOCATED  
ON THE SITE. WHERE TESTING  
WAS NOT CONDUCTED, THE  
BEDROCK CONTOURS WERE BASED  
ON EXISTING GRADE ELEVATIONS.

DATE	FIELD BY:	INT.
BK#	FIELD BOOK	PG#
5/18	CALCS BY:	RRG
5/18	DESIGNED BY:	RRG
5/18	DRAWN BY:	COMP
5/18	CHECKED BY:	CAQ

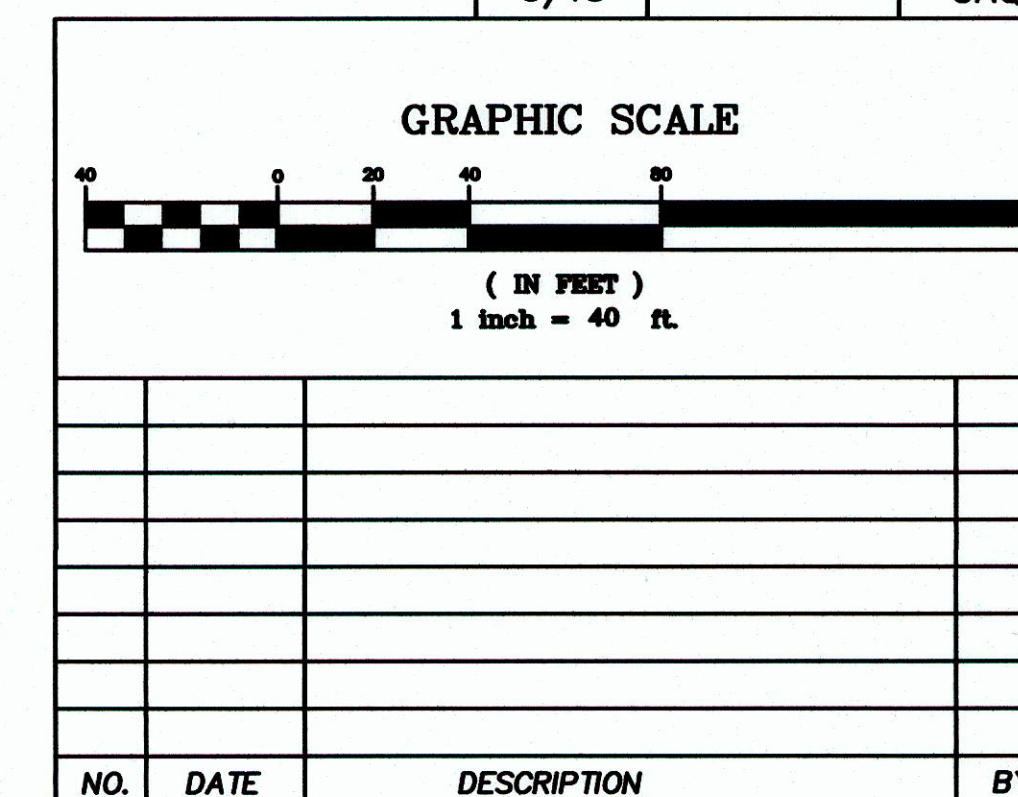

THE PRESERVE AT ABBYVILLE  
& ABBYVILLE COMMONS  
GRADING AND BEDROCK  
ILLUSTRATION PLAN  
NORFOLK, MASSACHUSETTS  
FOR  
ABBYVILLE DEVELOPMENT, LLC.  
& ABBYVILLE RESIDENTIAL, LLC  
850 FRANKLIN STREET  
WRENTHAM, MASSACHUSETTS  
DATE: MAY 17, 2018  
SCALE: 1" = 40'

**UNITED**  
**CONSULTANTS**  
**INC.**

850 FRANKLIN STREET SUITE 11D  
WRENTHAM, MASSACHUSETTS 02093  
508-384-6580 FAX 508-384-6586


DATE	MAY 17, 2018
SCALE	1" = 40'
PROJECT	UC987
SHEET	4 OF 8





NOTE:  
BEDROCK CONTOURS WERE  
PROVIDED BY GEO HYDRO CYCLE.  
THEY ARE BASED ON MONITOR  
WELLS AND TEST PITS LOCATED  
ON THE SITE. WHERE TESTING  
WAS NOT CONDUCTED, THE  
BEDROCK CONTOURS WERE BASED  
ON EXISTING GRADE ELEVATIONS.

DATE	FIELD BY:	INT.
BK#	FIELD BOOK	PG#
5/18	CALCS BY:	RRG
5/18	DESIGNED BY:	RRG
5/18	DRAWN BY:	COMP
5/18	CHECKED BY:	CAQ

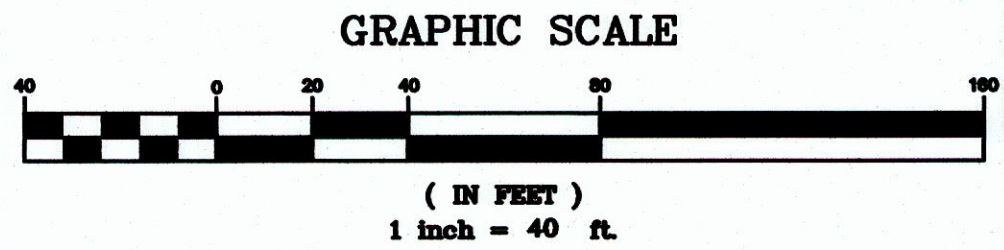



NO.	DATE	DESCRIPTION	BY

THE PRESERVE AT ABBYVILLE  
& ABBYVILLE COMMONS  
GRADING AND BEDROCK  
ILLUSTRATION PLAN  
NORFOLK, MASSACHUSETTS  
FOR  
ABBYVILLE DEVELOPMENT, LLC.  
& ABBYVILLE RESIDENTIAL, LLC  
850 FRANKLIN STREET  
WRENTHAM, MASSACHUSETTS  
DATE: MAY 17, 2018  
SCALE: 1" = 40'

**UNITED**  
**CONSULTANTS**  
**INC.**  
850 FRANKLIN STREET SUITE 11D  
WRENTHAM, MASSACHUSETTS 02093  
508-384-6560 FAX 508-384-6566

DATE	MAY 17, 2018
SCALE	1" = 40'
PROJECT	UC987
SHEET	5 OF 8



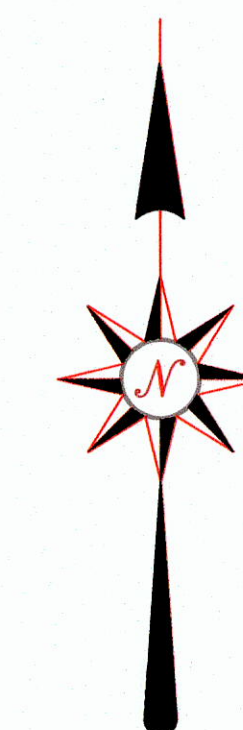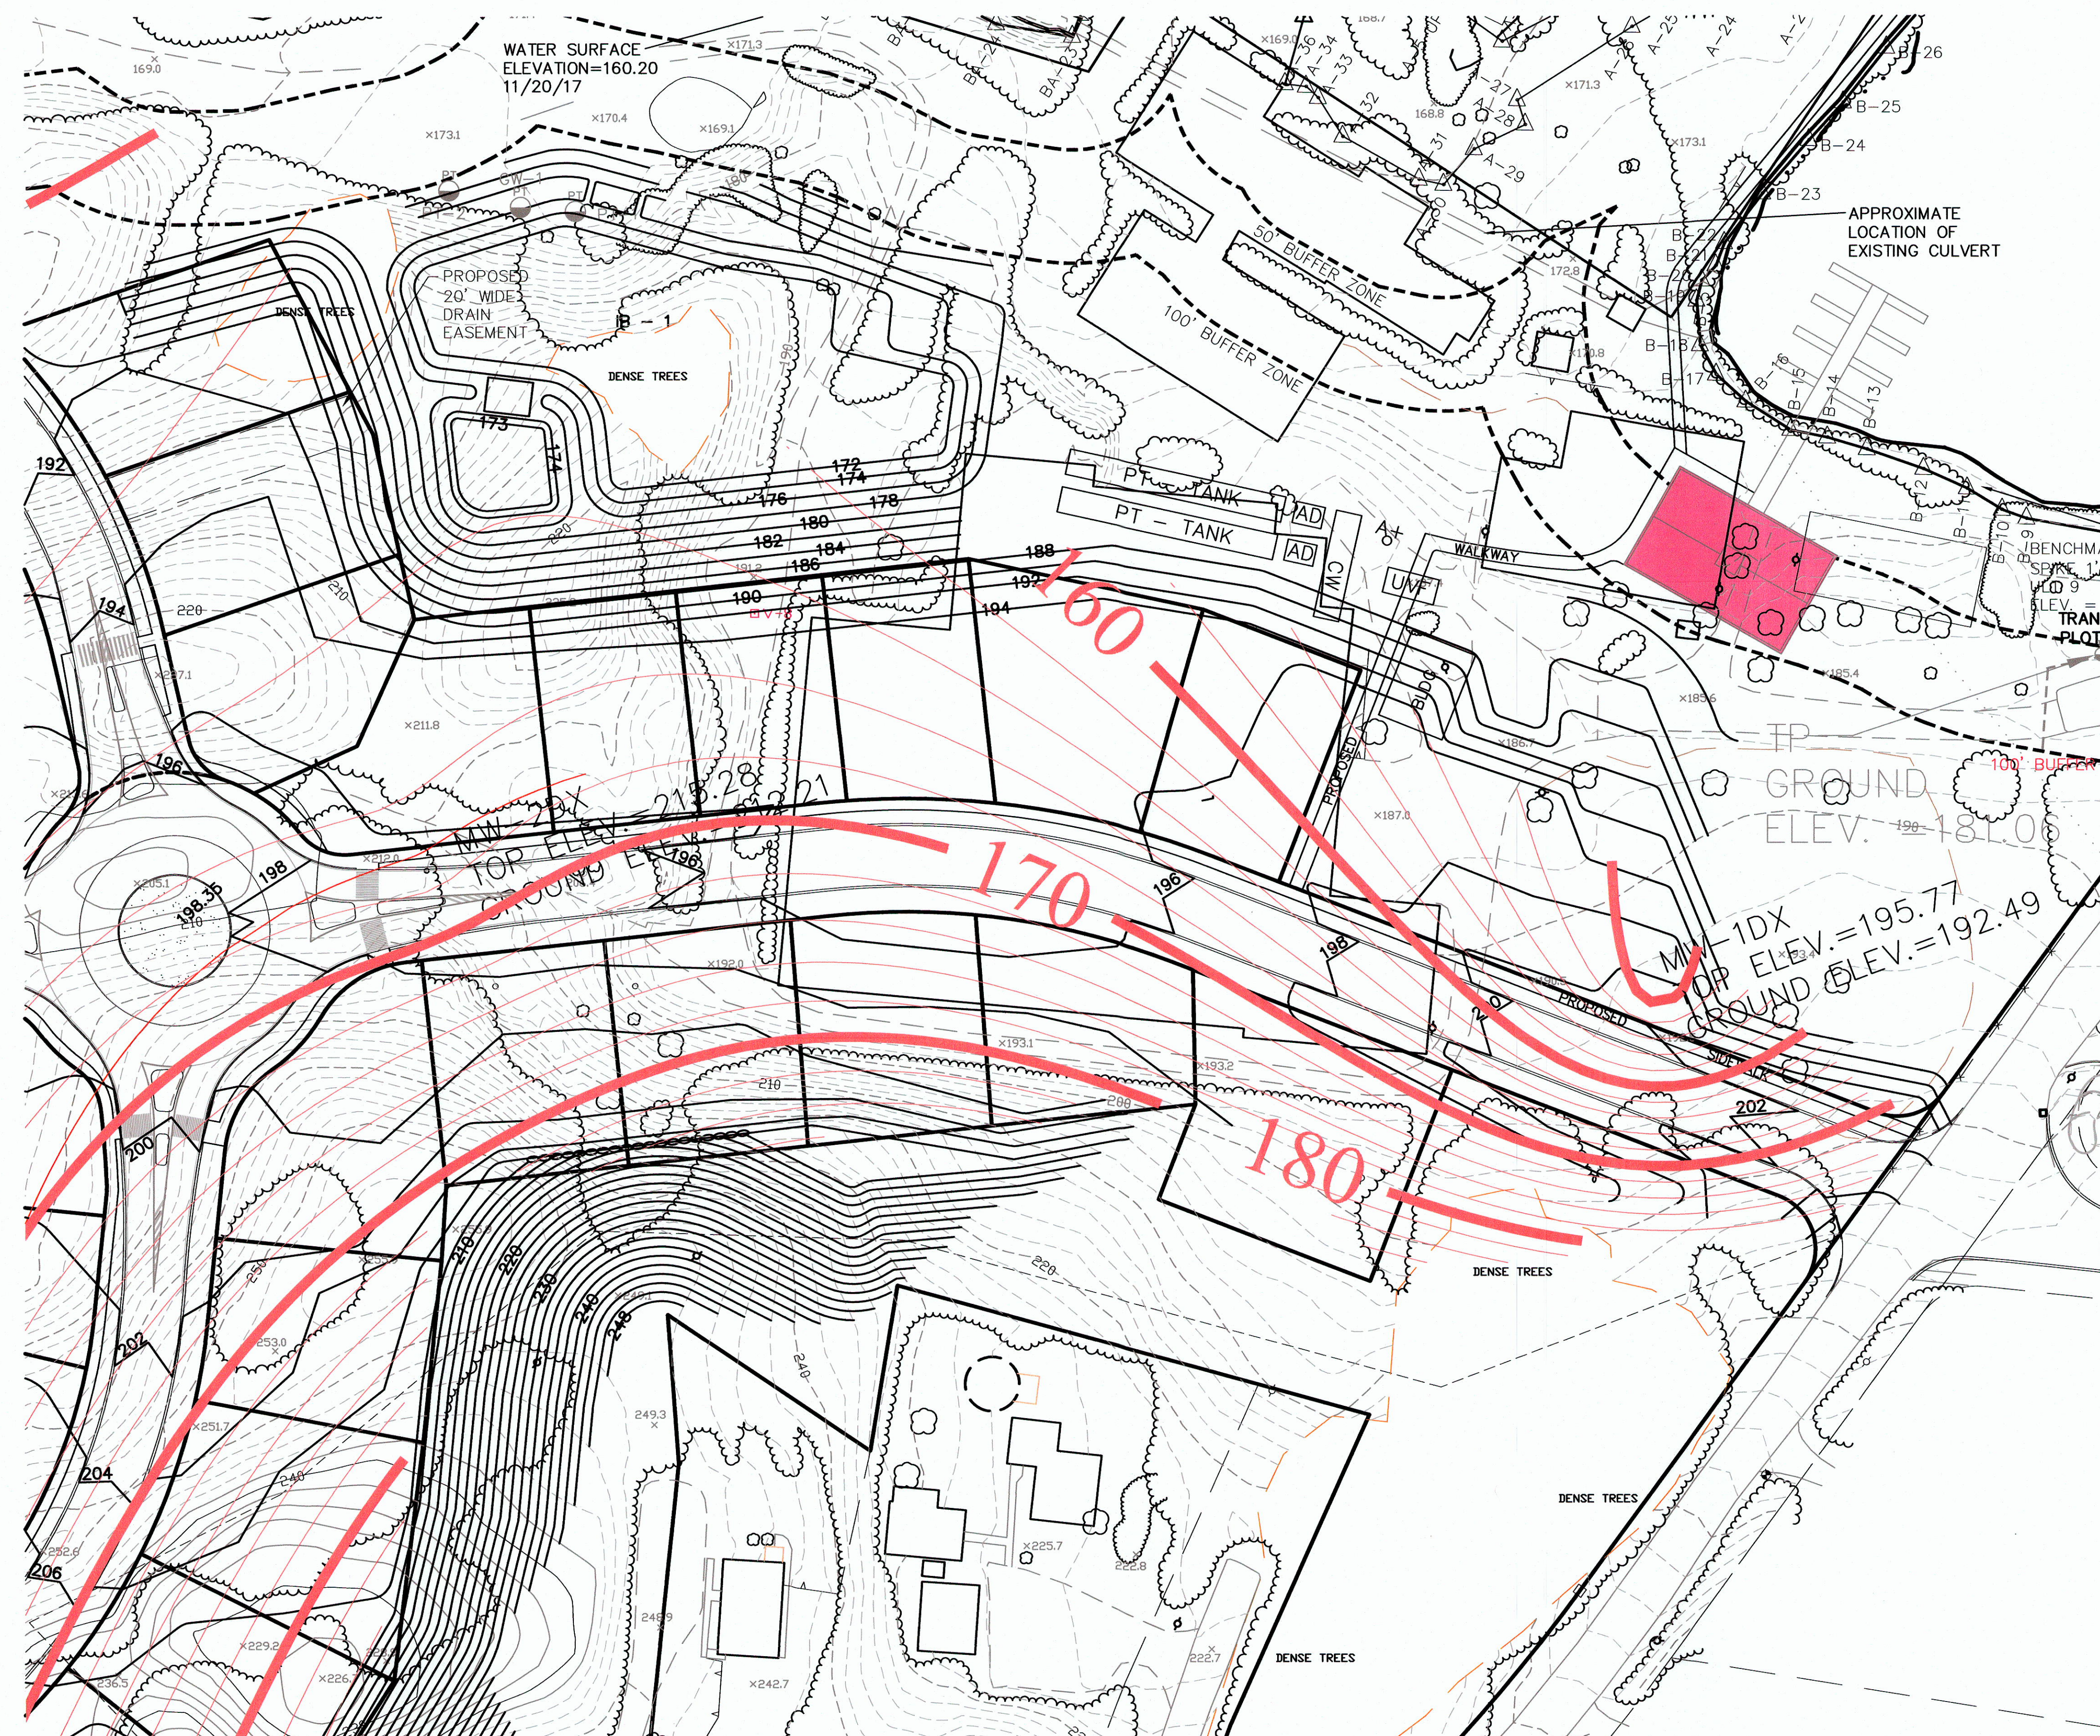

NOTE:  
BEDROCK CONTOURS WERE  
PROVIDED BY GEO HYDRO CYCLE.  
THEY ARE BASED ON MONITOR  
WELLS AND TEST PITS LOCATED  
ON THE SITE. WHERE TESTING  
WAS NOT CONDUCTED, THE  
BEDROCK CONTOURS WERE BASED  
ON EXISTING GRADE ELEVATIONS.

### GRAPHIC SCALE

( IN FEET )  
1 inch = 40 ft.

THE PRESERVE AT ABBYVILLE  
& ABBYVILLE COMMONS  
GRADING AND BEDROCK  
ILLUSTRATION PLAN  
NORFOLK, MASSACHUSETTS  
FOR  
ABBYVILLE DEVELOPMENT, LLC.  
& ABBYVILLE RESIDENTIAL, LLC  
850 FRANKLIN STREET  
WRENTHAM, MASSACHUSETTS  
DATE: MAY 17, 2018  
SCALE: 1" = 40'

**UNITED  
CONSULTANTS  
INC.**  
850 FRANKLIN STREET SUITE 11D  
WRENTHAM, MASSACHUSETTS 02093  
508-384-6560 FAX 508-384-6566










NOTE:  
BEDROCK CONTOURS WERE  
PROVIDED BY GEO HYDRO CYCLE.  
THEY ARE BASED ON MONITOR  
WELLS AND TEST PITS LOCATED  
ON THE SITE. WHERE TESTING  
WAS NOT CONDUCTED, THE  
BEDROCK CONTOURS WERE BASED  
ON EXISTING GRADE ELEVATIONS.

DATE	FIELD BY:	INT.
BK#	FIELD BOOK	PG#
5/18	CALCS BY: RRG	
5/18	DESIGNED BY: RRG	
5/18	DRAWN BY: COMP	
5/18	CHECKED BY: CAQ	

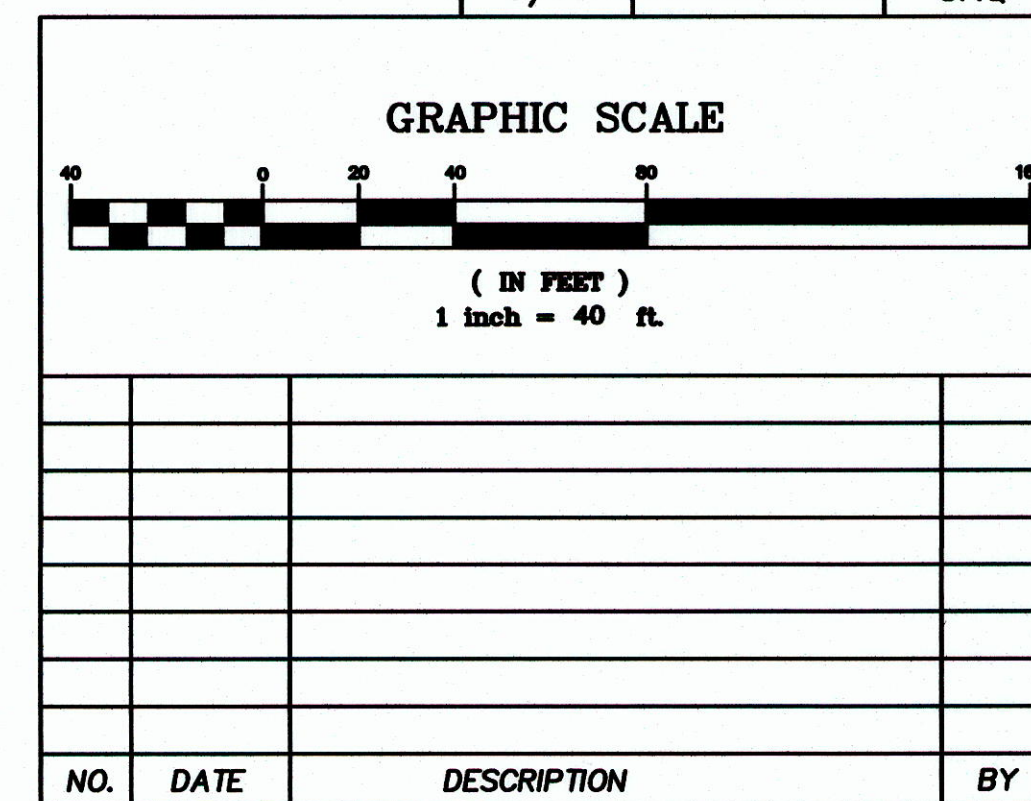

THE PRESERVE AT ABBYVILLE  
& ABBYVILLE COMMONS  
GRADING AND BEDROCK  
ILLUSTRATION PLAN  
NORFOLK, MASSACHUSETTS  
FOR  
ABBYVILLE DEVELOPMENT, LLC.  
& ABBYVILLE RESIDENTIAL, LLC  
850 FRANKLIN STREET  
WRENTHAM, MASSACHUSETTS  
DATE: MAY 17, 2018  
SCALE: 1" = 40'

**UNITED**  
**CONSULTANTS**  
**INC.**  
850 FRANKLIN STREET SUITE 11D  
WRENTHAM, MASSACHUSETTS 02093  
508-384-8580 FAX 508-384-8588

DATE	MAY 17, 2018
SCALE	1" = 40'
PROJECT	UC987
SHEET	8 OF 8